


FAMILY VIDEO
SITE PLAN

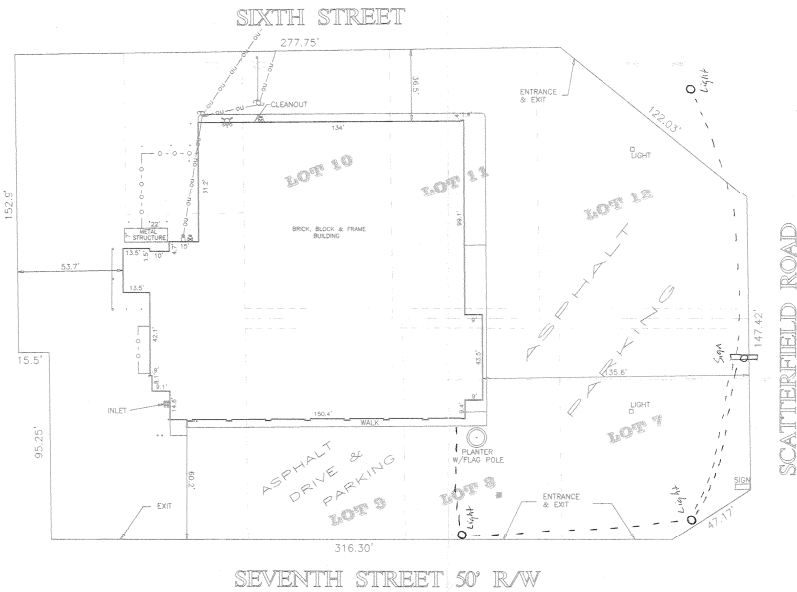

LEGEND

- = GUARD POST
- ⊕ = GAS METER
- ⊖ = ELECTRIC METER
- ⊕ = OVERHEAD POWER
- ⊖ = POWER POLE
- o — = FENCE
- = GUARD RAIL

NOTE:
SOME ITEMS MAY NOT BE SHOWN
DUE TO HEAVY SNOW COVER

615 ST. RD. 9
ANDERSON, IN.



REV. DATE	BY	DESCRIPTION

Lower Electric
Jimmy Kowen

Edward D. Miller
16 4 JAN 2001



MILLER SURVEYING INC. <small>248 CONNER STREET HOOSIERSVILLE INDIANA 46000 Ph. # (317) 773-2644 FAX 773-2884</small>	
LOCATION: LOTS 7, 8, 9, 10, 11, 12, INEL 1ST. ADD. SECTION 7-10-3 MADISON CO., INDIANA	DRAWN BY: AC SCALE: 1" = 30' DATE: 1-2-01 JOB NUMBER: B26949
FIELD WORK COMPLETED: 12-26-00 CLIENT: ROCKFORD CONCRETE	CHK'D BY: L.D.M. FIELD BOOK: PAGE: SURVEY 4 FILE

Anderson is built